

Revisions


VOICE: (520) 791-2060
 FAX: (520) 791-2061



YUMA ADULT DETENTION CENTER HVAC REPLACE
 141 S THIRD AVENUE
 YUMA, AZ 85364
MECHANICAL DEMOLITION ROOF PLAN

Date: 2/2/24
 Drawn By: JHB | Checked By: PEH
 Scale: AS NOTED
 Project Number: 23341
 Sheet:

M0.3


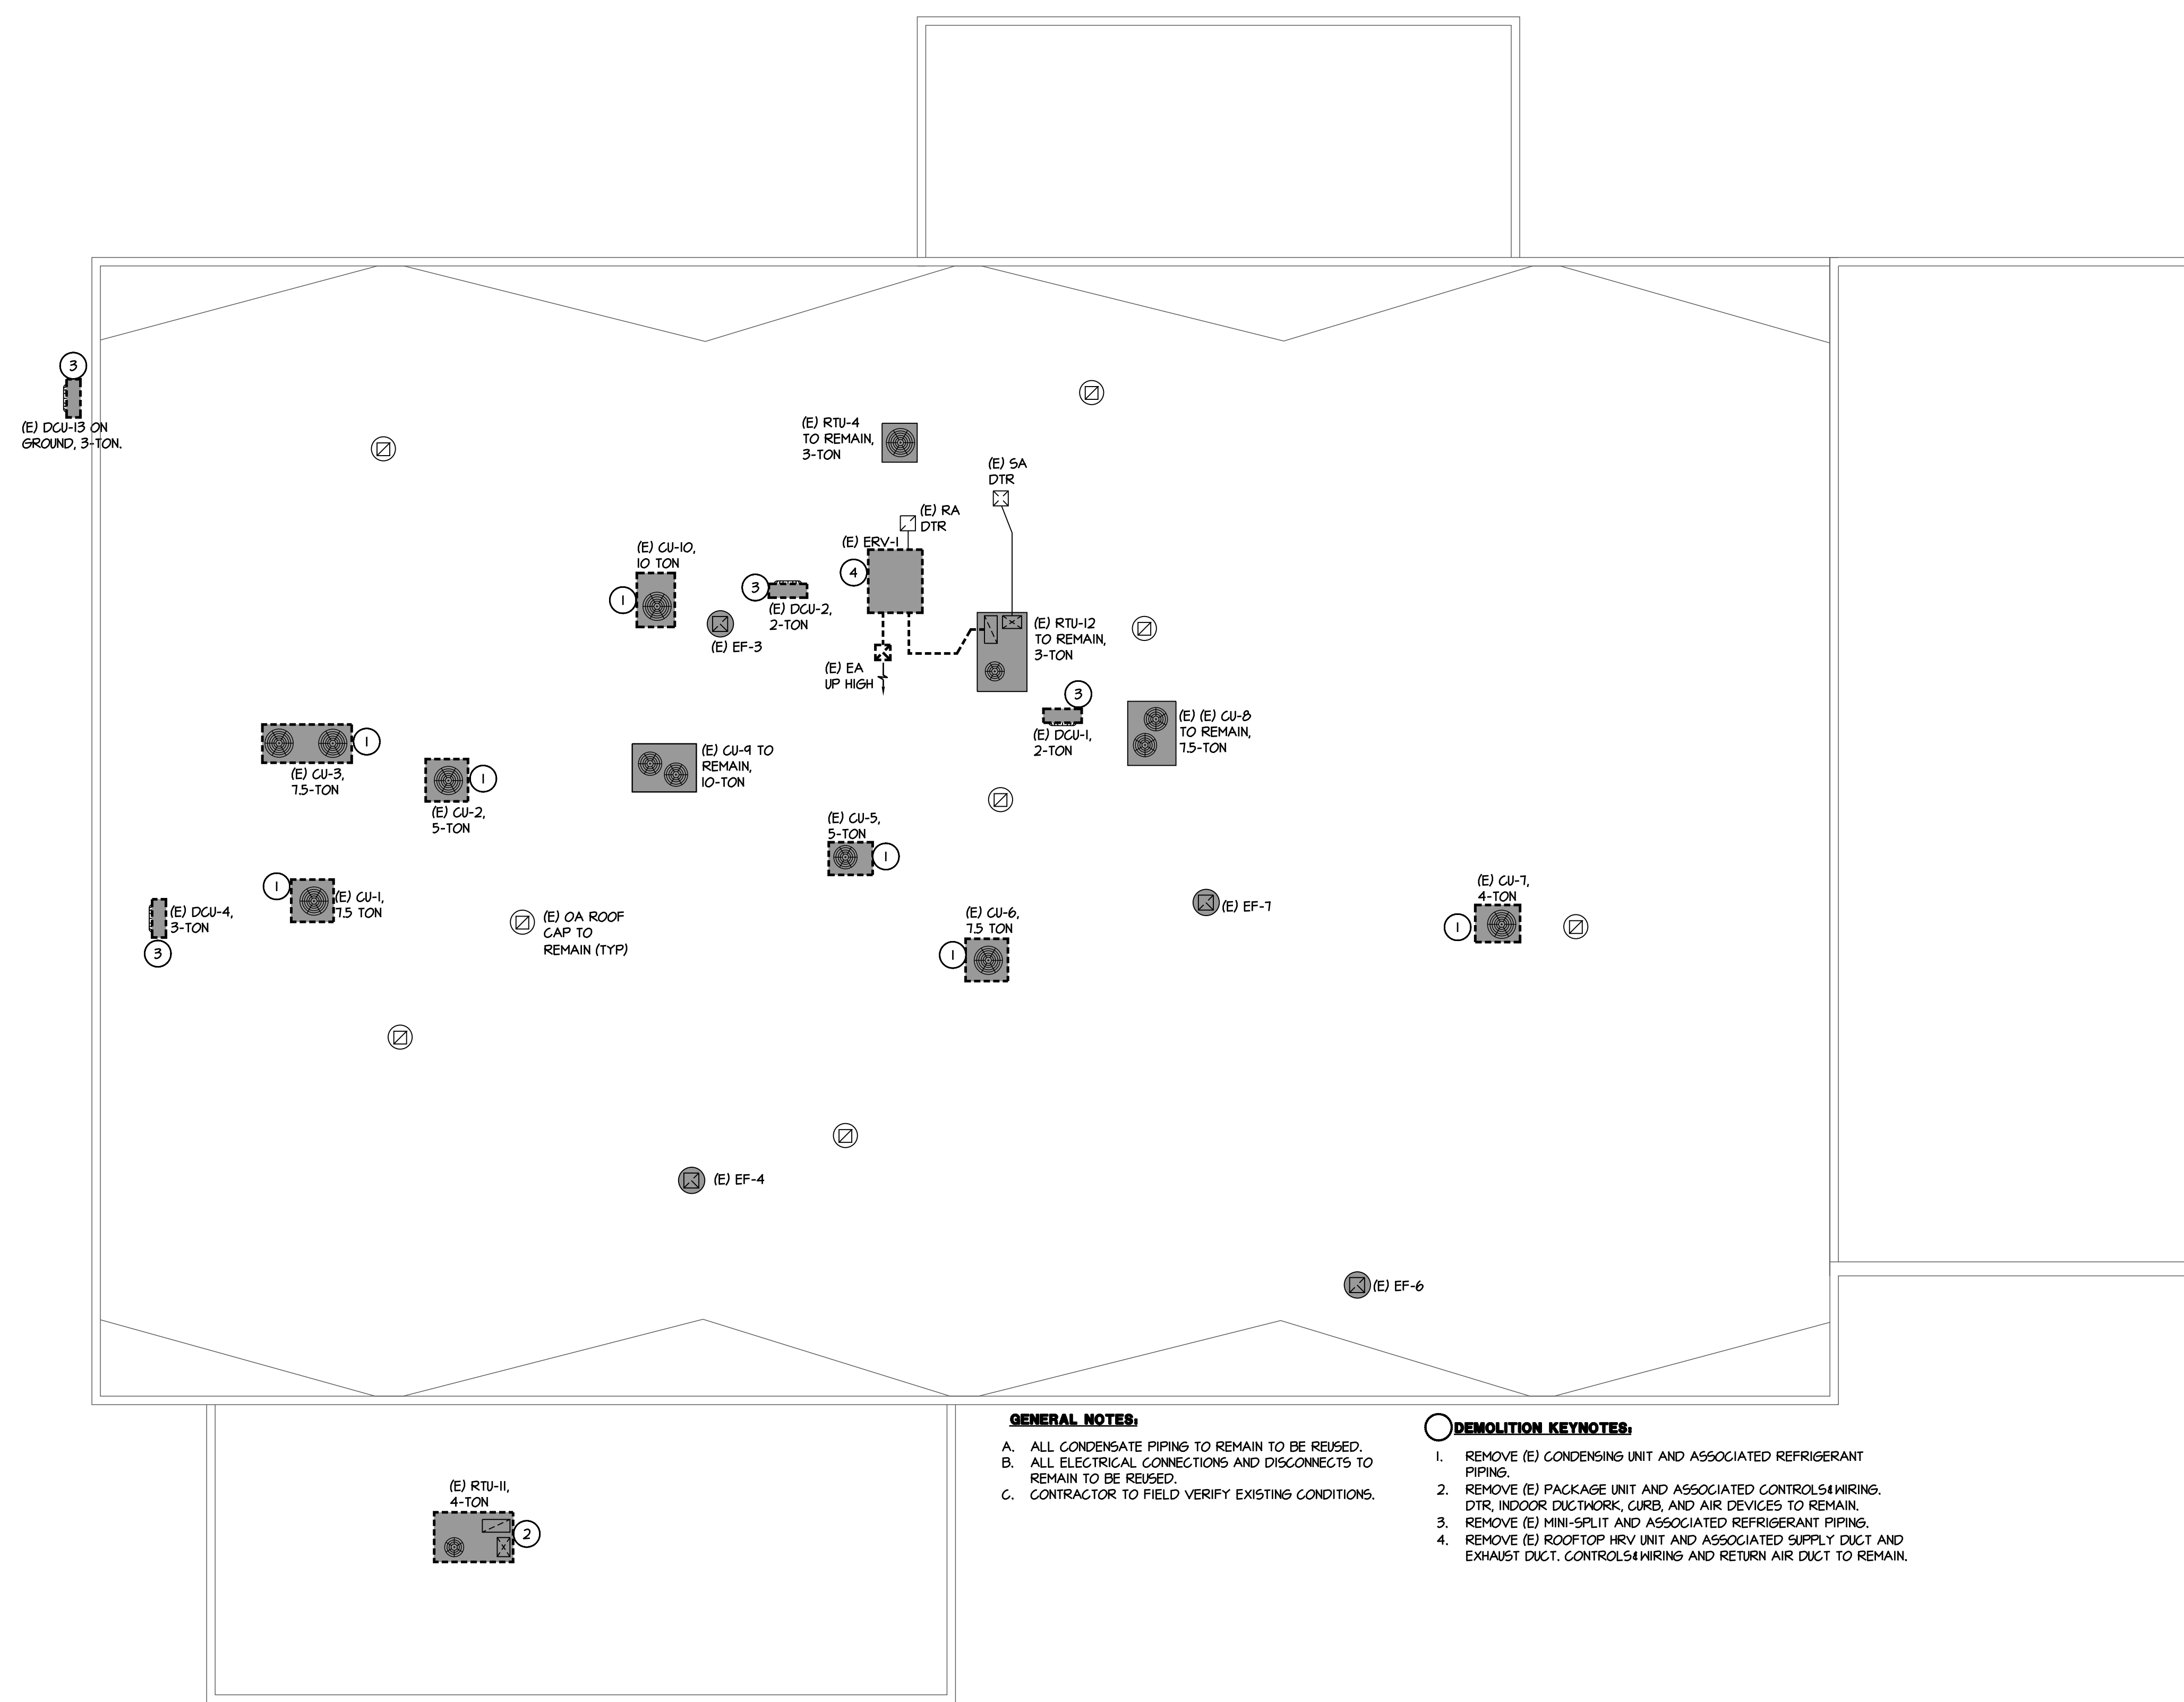


- MECHANICAL DEMOLITION NOTES**
- COORDINATE DEMOLITION OF ALL OVERHEAD HVAC ITEMS WITH OTHER TRADES.
 - ALL DUCTWORK SHALL REMAIN, UNO.
 - ALL AIR DEVICES SHALL REMAIN, UNO.
 - ALL EXHAUST FANS SHALL REMAIN, UNO.
 - COORDINATE DEMOLITION SCHEDULE AND HOURS OF WORK WITH THE OWNER AND/OR ARCHITECT.
 - CONTRACTOR SHALL MAINTAIN PREMISES IN CLEAN CONDITION AT END OF EACH DAY AND THOROUGHLY CLEAN-UP AT END OF CONSTRUCTION.
 - COORDINATE PROPER DISPOSAL OF ALL DEMOLITION ITEMS WITH OWNER AND/OR ARCHITECT.
 - THE CONTRACTOR SHALL FIELD VERIFY ALL EXISTING CONDITIONS PRIOR TO STARTING WORK.

- GENERAL NOTES:**
- ALL CONDENSATE PIPING TO REMAIN TO BE REUSED.
 - ALL ELECTRICAL CONNECTIONS AND DISCONNECTS TO REMAIN TO BE REUSED.
 - CONTRACTOR TO FIELD VERIFY EXISTING CONDITIONS.

- DEMOLITION KEYNOTES:**
- REMOVE (E) CONDENSING UNIT AND ASSOCIATED REFRIGERANT PIPING.
 - REMOVE (E) PACKAGE UNIT AND ASSOCIATED CONTROLS WIRING, DTR, INDOOR DUCTWORK, CURB, AND AIR DEVICES TO REMAIN.
 - REMOVE (E) MINI-SPLIT AND ASSOCIATED REFRIGERANT PIPING.
 - REMOVE (E) ROOFTOP HRV UNIT AND ASSOCIATED SUPPLY DUCT AND EXHAUST DUCT, CONTROLS WIRING AND RETURN AIR DUCT TO REMAIN.

MECHANICAL DEMO ROOF PLAN
 SCALE: 1/8" = 1'-0"

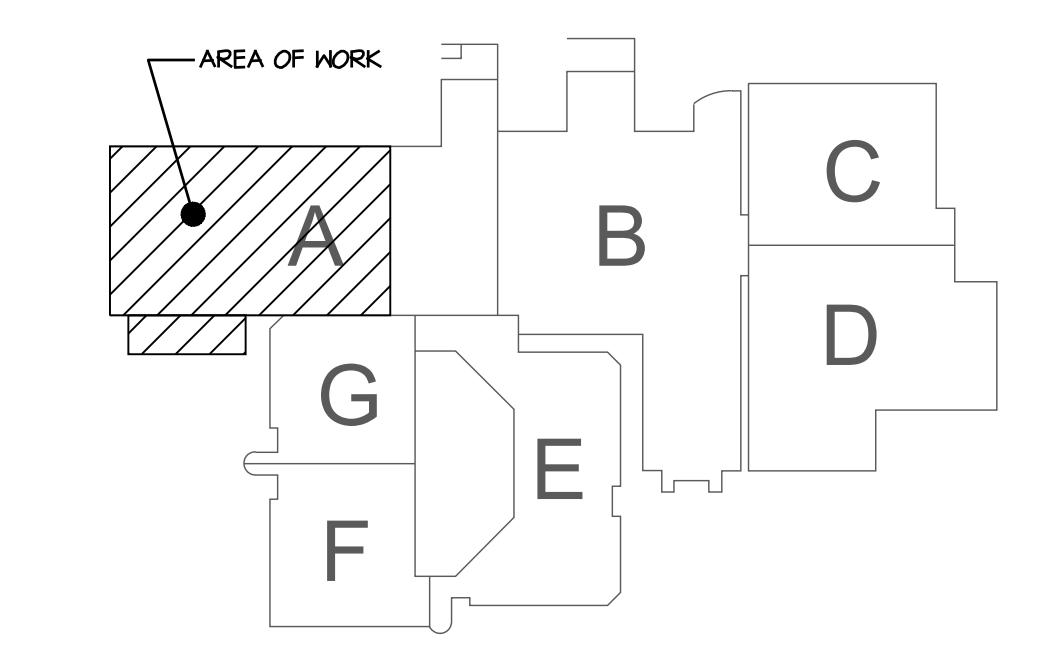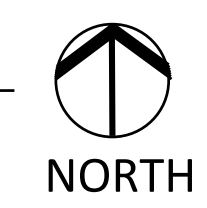

KEYPLAN
 NTS

